

电力	暖通	动力
结构	给排水	
暖通	给排水	
结构	给排水	
暖通	给排水	
结构	给排水	
暖通	给排水	
结构	给排水	
暖通	给排水	
结构	给排水	

TYPE 6 design, 1 units



Copyright 2016.

本图版权归浙江普天集成房屋有限公司所有，基本工程对本图的所有权已用技术措施保护。
 THE OWNERSHIP OF THE COPYRIGHT IN THIS DRAWING IS RETAINED BY ZHEJIANG PUTIAN INTEGRATED HOUSING CO.,LTD. WRITTEN CONSENT MUST BE OBTAINED BEFORE ANY USE OR REPRODUCTION OF THE DRAWING.

版本 Rev.	修改内容 Description	日期 Date	负责人 who send

PTH

Zhejiang Putian integrated housing Co., Ltd.
 Hangzhou Zhongyu Architecture Design (Institute) Co., Ltd.

证书等级	
证书编号	

合作设计单位
 Cooperative Designer

工序 Process	签名 Signature	日期 Date
审定 Authorized By		
审核 Verified By		
项目负责人 Process		
校对人 Checked By		
设计 Designed By		
制图 Drawn By		

执业印章
 Engineer Signature

出图印章
 Engineer Signature

项目名称
 Project Name

澳大利亚-集装箱

题名
 Title

3D

工程编号 No.	PT220307	专业 Prof.	JZ
比例 Scale		图号 Drawing No.	J0-1

未盖技术出图章 本图纸无效
 This drawing is valid only after being stamped and
 This drawing is invalid without the stamp.

Copyright 2016.

本图版权归浙江普利集成房屋有限公司所有。基本工图中所有的标注均须标注单位和规格。
THE OWNERSHIP OF THE COPYRIGHT IN THIS DRAWING REMAINS BY ZHEJIANG PUTIAN INTEGRATED HOUSING CO., LTD. WRITTEN CONSENT MUST BE OBTAINED BEFORE RE-USE OR REPRODUCTION OF THE DRAWING.


版本 Rev	修改内容 Description	日期 Date	负责人 who send
-----------	---------------------	------------	-----------------

PTH

Zhejiang Putian Integrated Housing Co., Ltd.
Hangzhou Zhonggu Architecture Design (Institute) Co., Ltd.

证书等级	
证书编号	

合作设计单位
Cooperative Designer

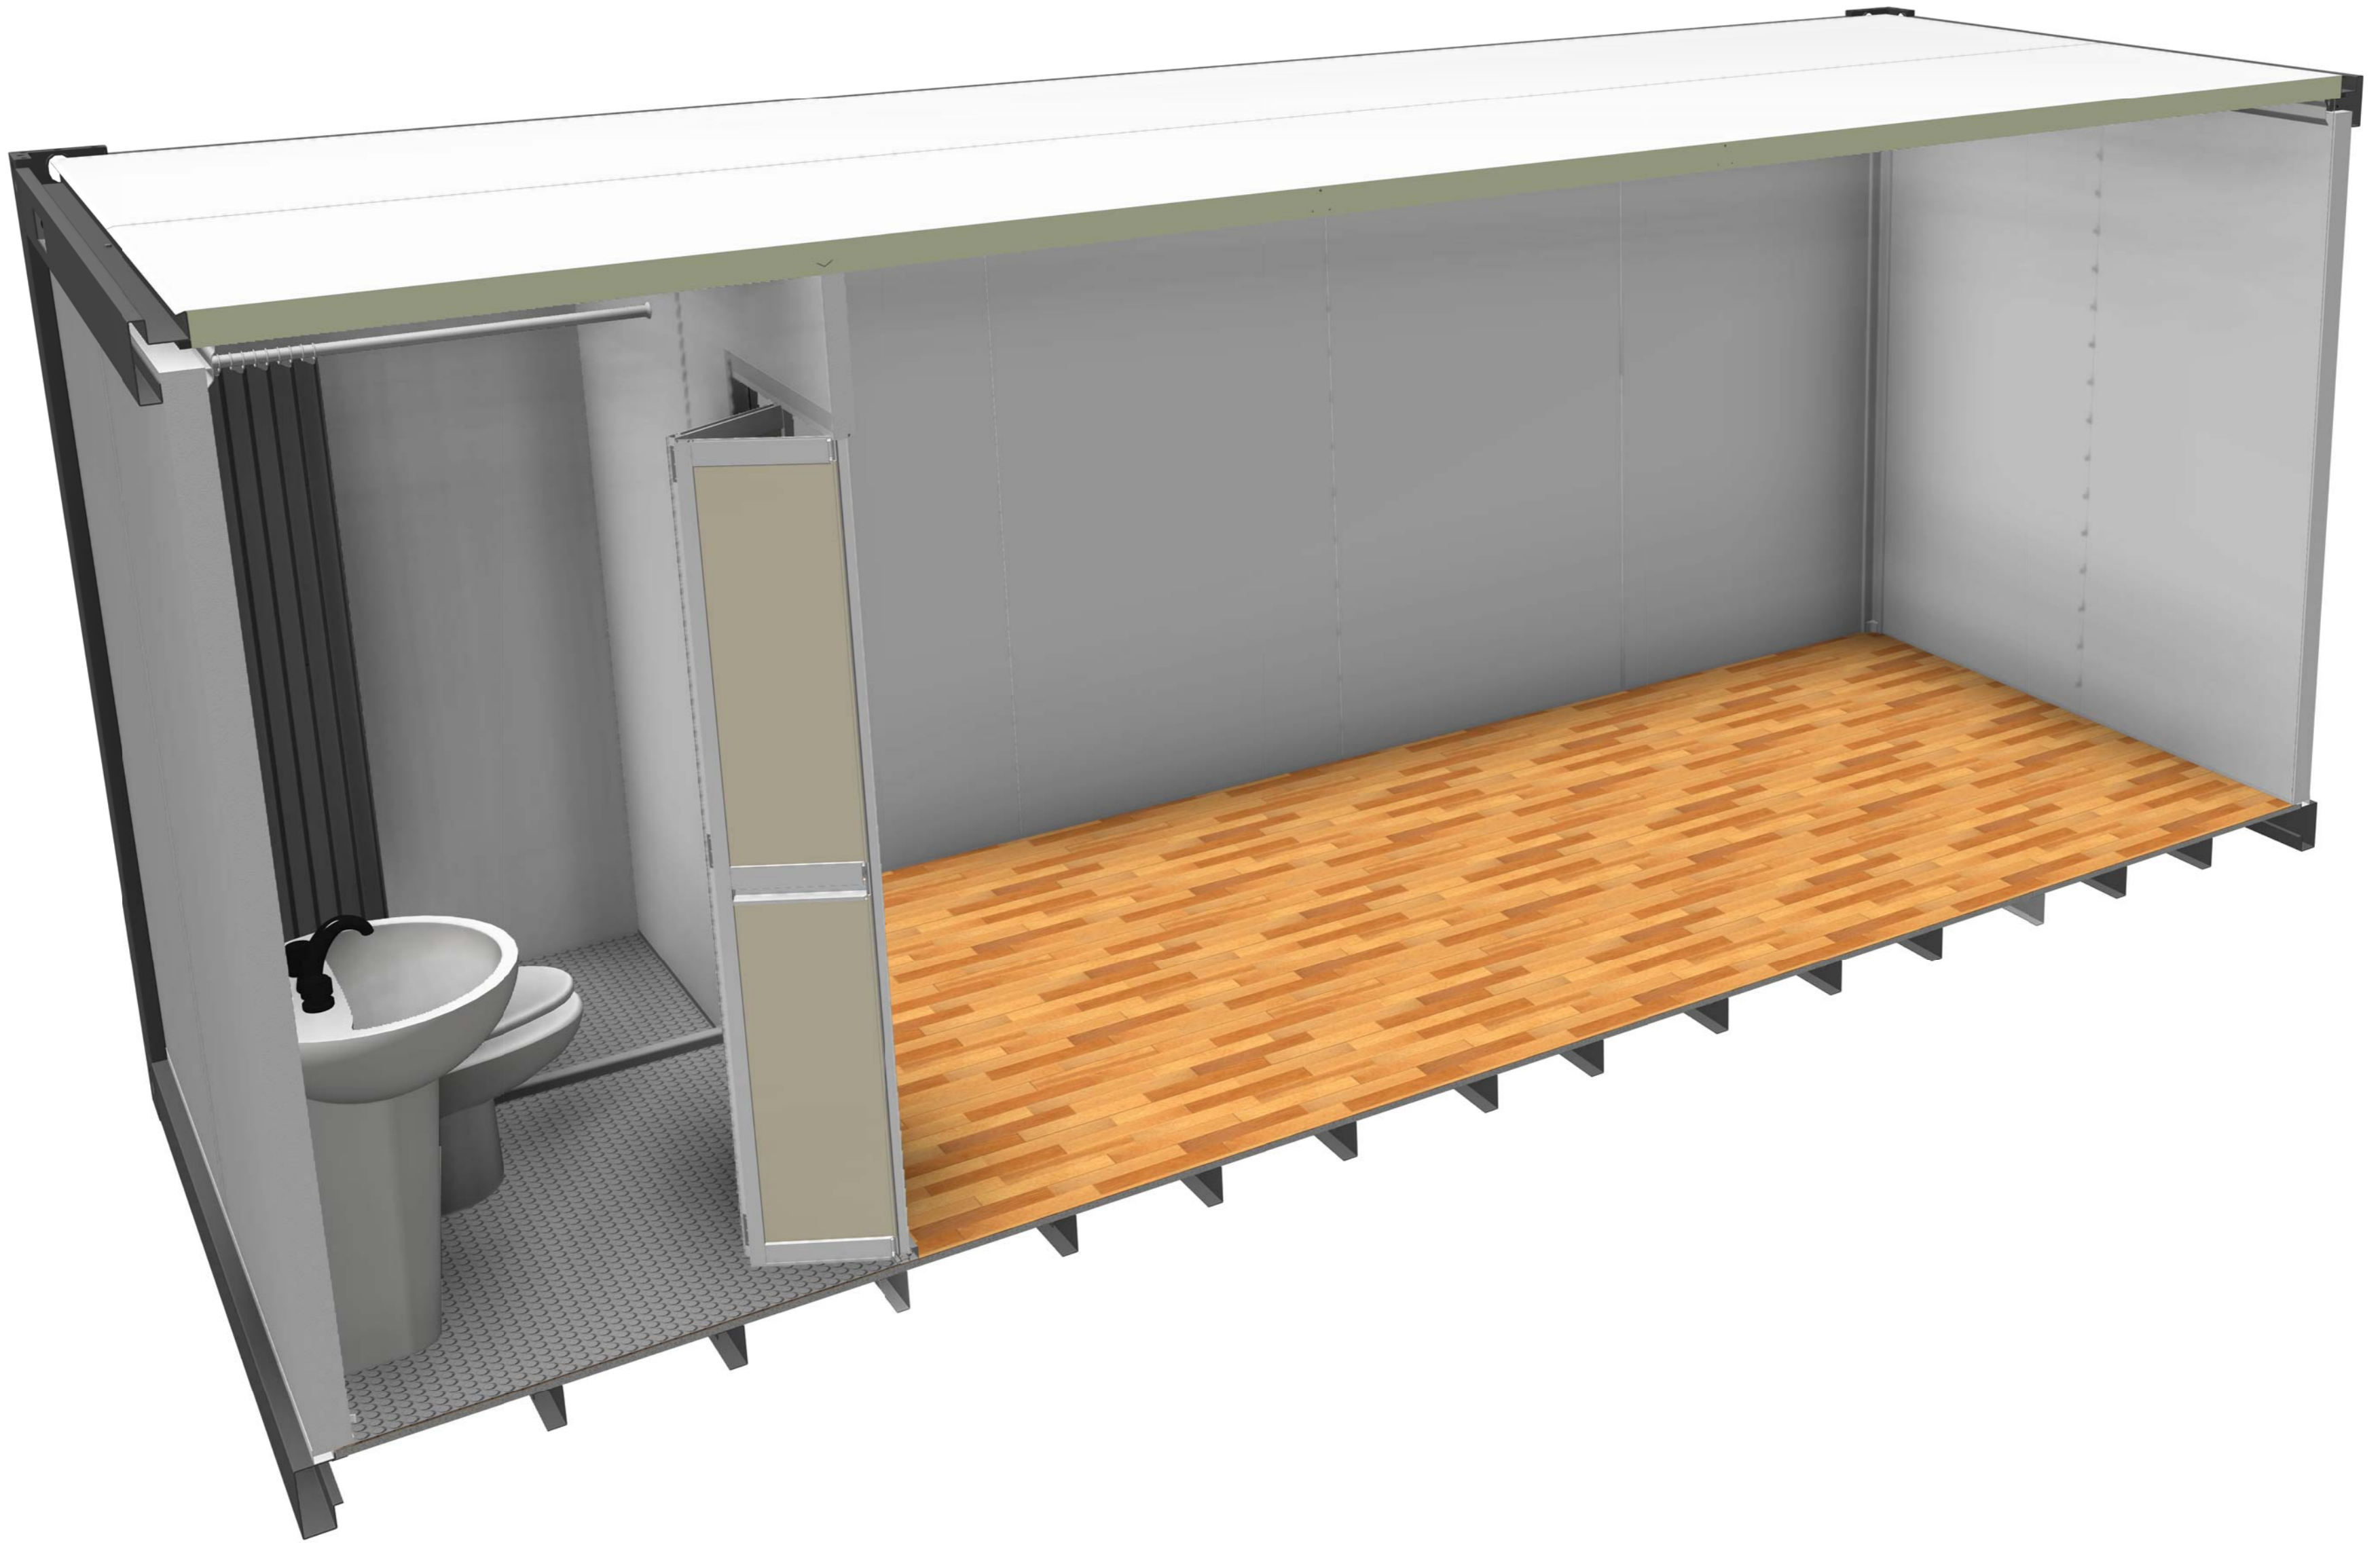

工序 Process	签名 Signature	日期 Date
审定 Authorized By		
审核 Verified By		
项目负责人 Process		
校对人 Checked By		
设计 Designed By		
制图 Drawn By		

执业印章
Engineer Signature

出图印章
Engineer Signature

项目名称
Project Name

澳大利亚-集装箱

题名
Title

3D


工程编号 ID	PT220307	专业 Prof.	JZ
------------	----------	-------------	----

比例 Scale	1:1	图号 No.	J0-2
-------------	-----	-----------	------

未盖技术出图章 本图纸无效
This drawing is valid only after being stamped and
without technical drawing stamp, this drawing is invalid.

动力	
暖通	
给排水	
电气	
结构	
建筑	
会签	
密封	

会	理	电
密	质	力
密	构	源
	造	动
	水	力

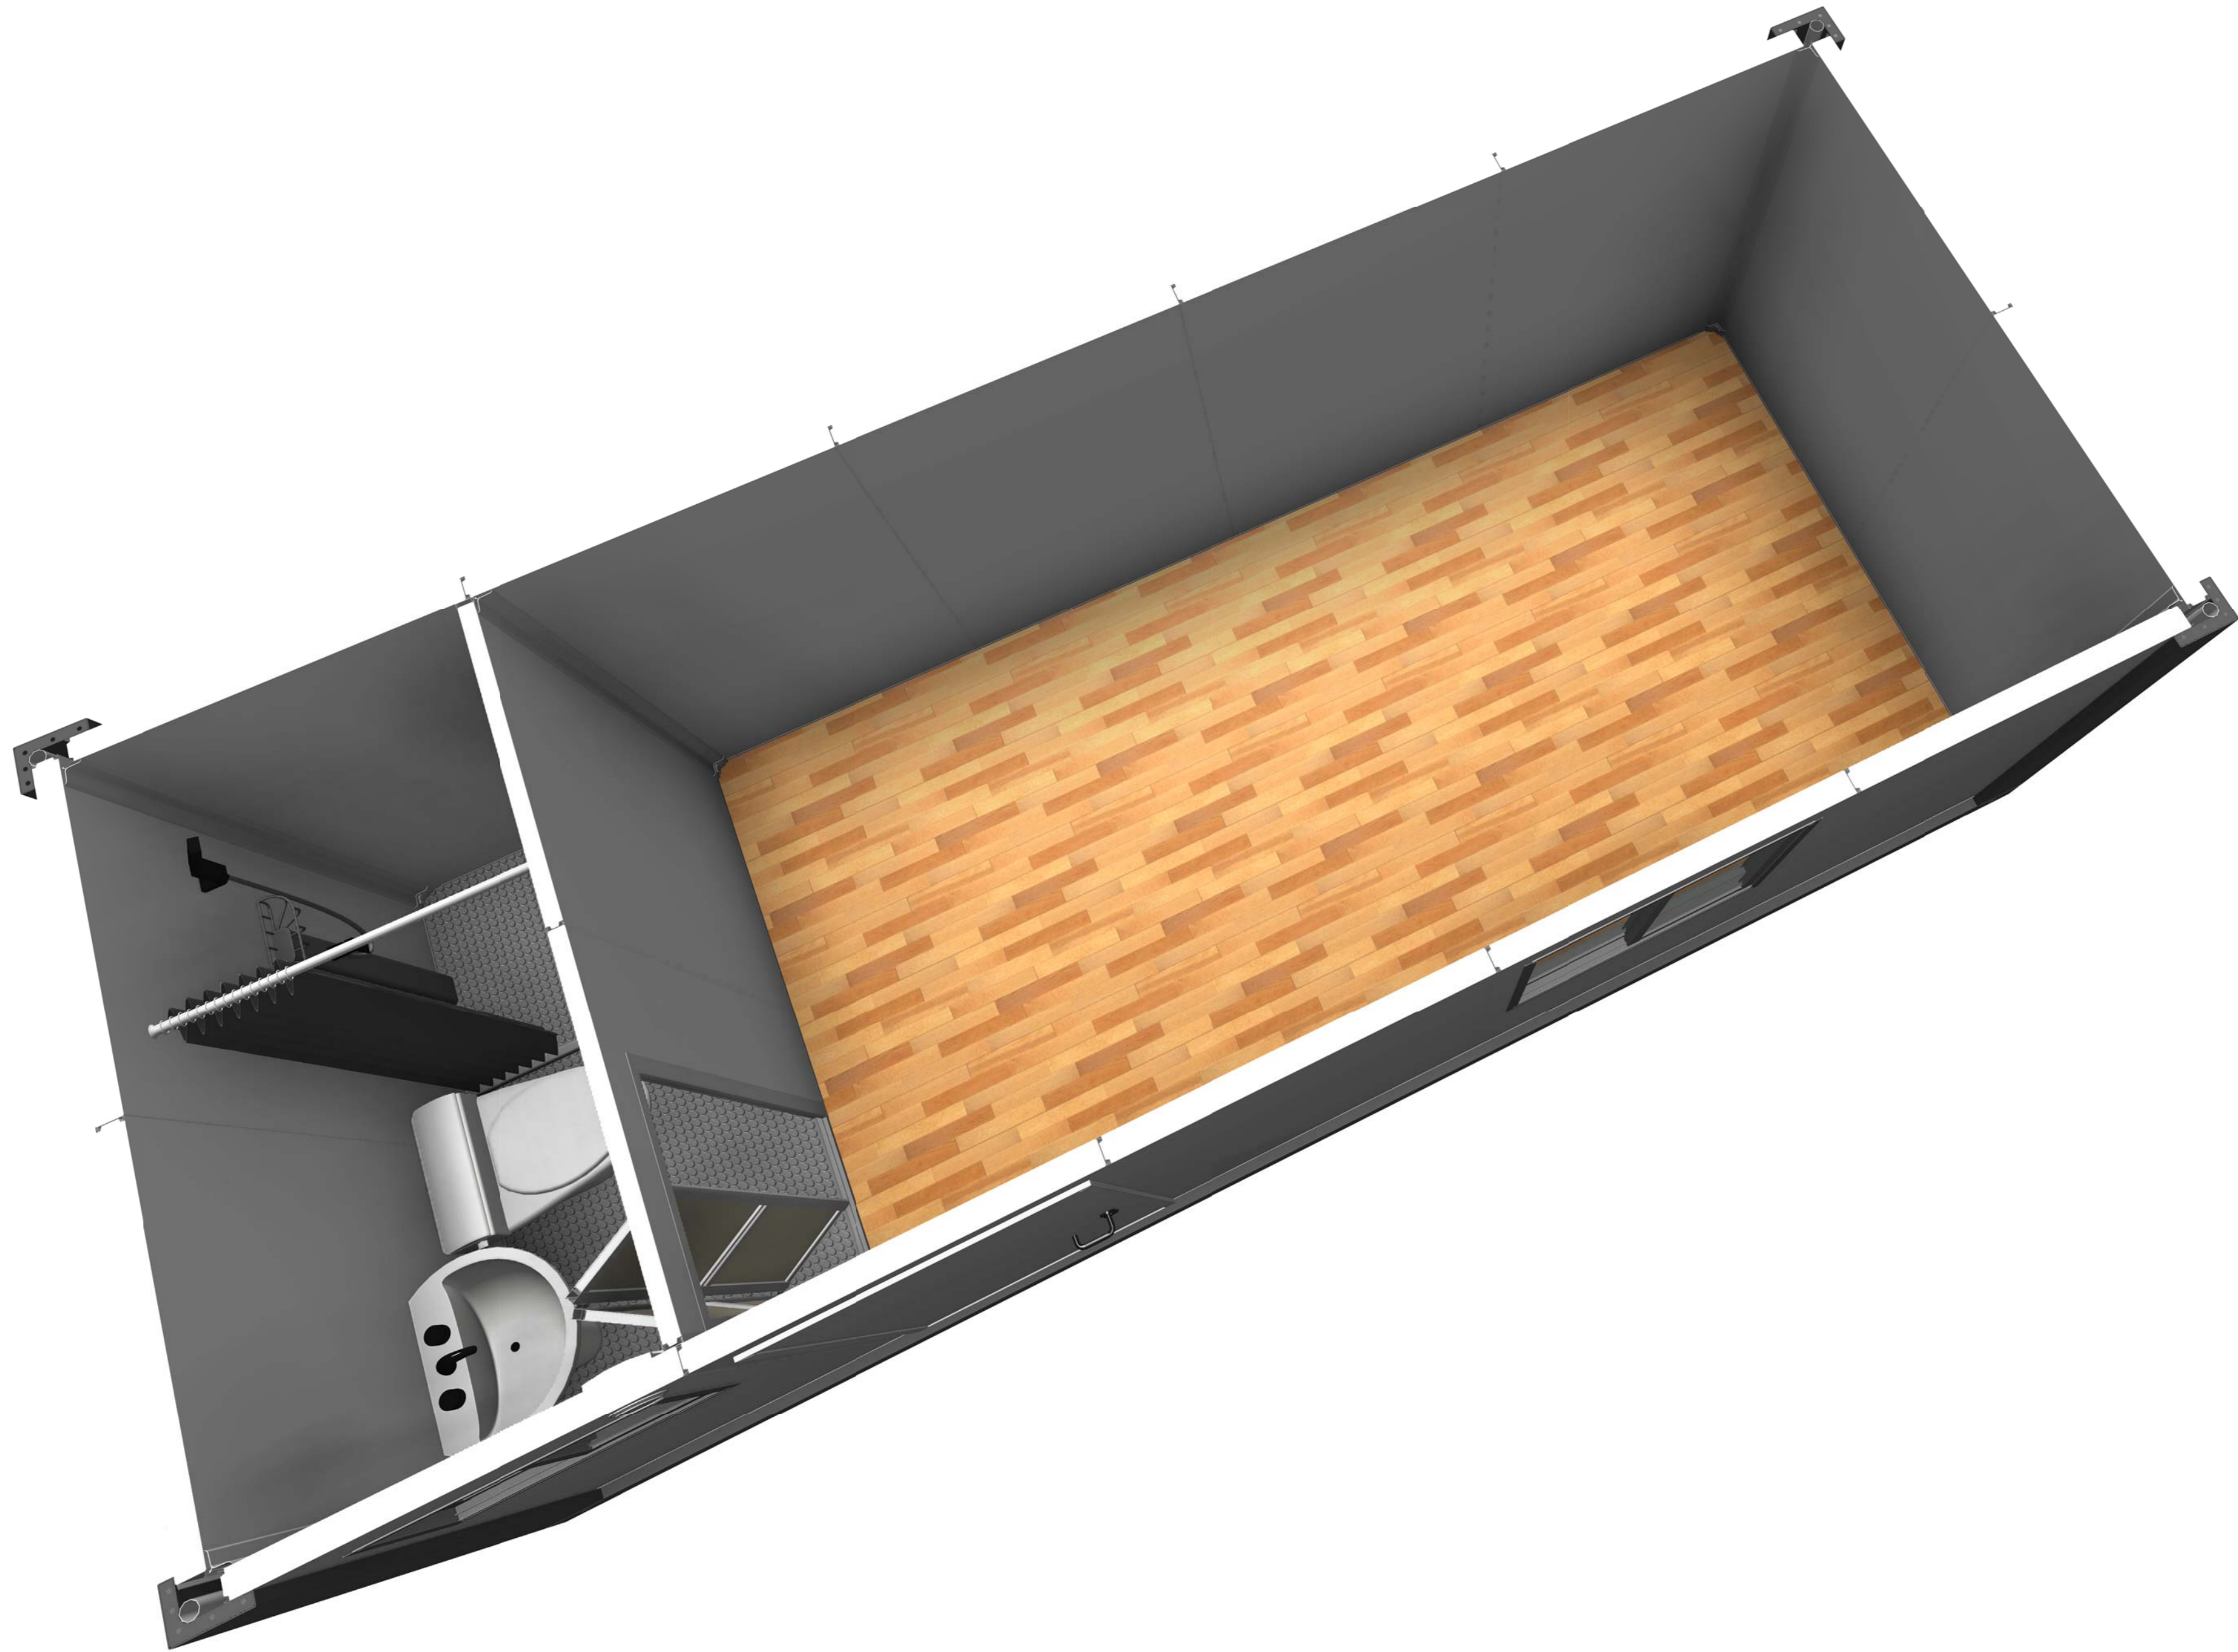

Copyright 2016.
 本图版权归浙江普天集成房屋有限公司所有，基本工图中本图的所有权归浙江普天集成房屋有限公司所有。
 THE OWNERSHIP OF THE COPYRIGHT IN THIS DRAWING REMAINS BY ZHEJIANG PUTIAN INTEGRATED HOUSING CO., LTD. WRITTEN CONSENT MUST BE OBTAINED BEFORE ANY USE OR REPRODUCTION OF THE DRAWING.

版本	修改内容	日期	负责人
Rev.	Description	Date	who send



Zhejiang Putian integrated housing Co., Ltd.
 Hangzhou Zhonggu Architecture Design (Institute) Co., Ltd.

证书等级	
证书编号	

合作设计单位
 Cooperative Designer

工序	签名	日期
Process	Signature	Date
审定		
Authorized By		
审核		
Verified By		
项目负责人		
Process		
校对人		
Checked By		
设计		
Designed By		
制图		
Drawn By		

执业签章
 Engineer Signature

出图签章
 Engineer Signature


项目名称
 Project Name
澳大利亚-集装箱

题名
3D

工程编号	PT220307	专业	JZ
比例		图号	J0-3

未盖技术出图章 本图纸无效
 This drawing is valid only after being stamped and
 This drawing is invalid if not stamped.

电力	暖通	动力
结构	给排水	
暖通		
给排水		
动力		

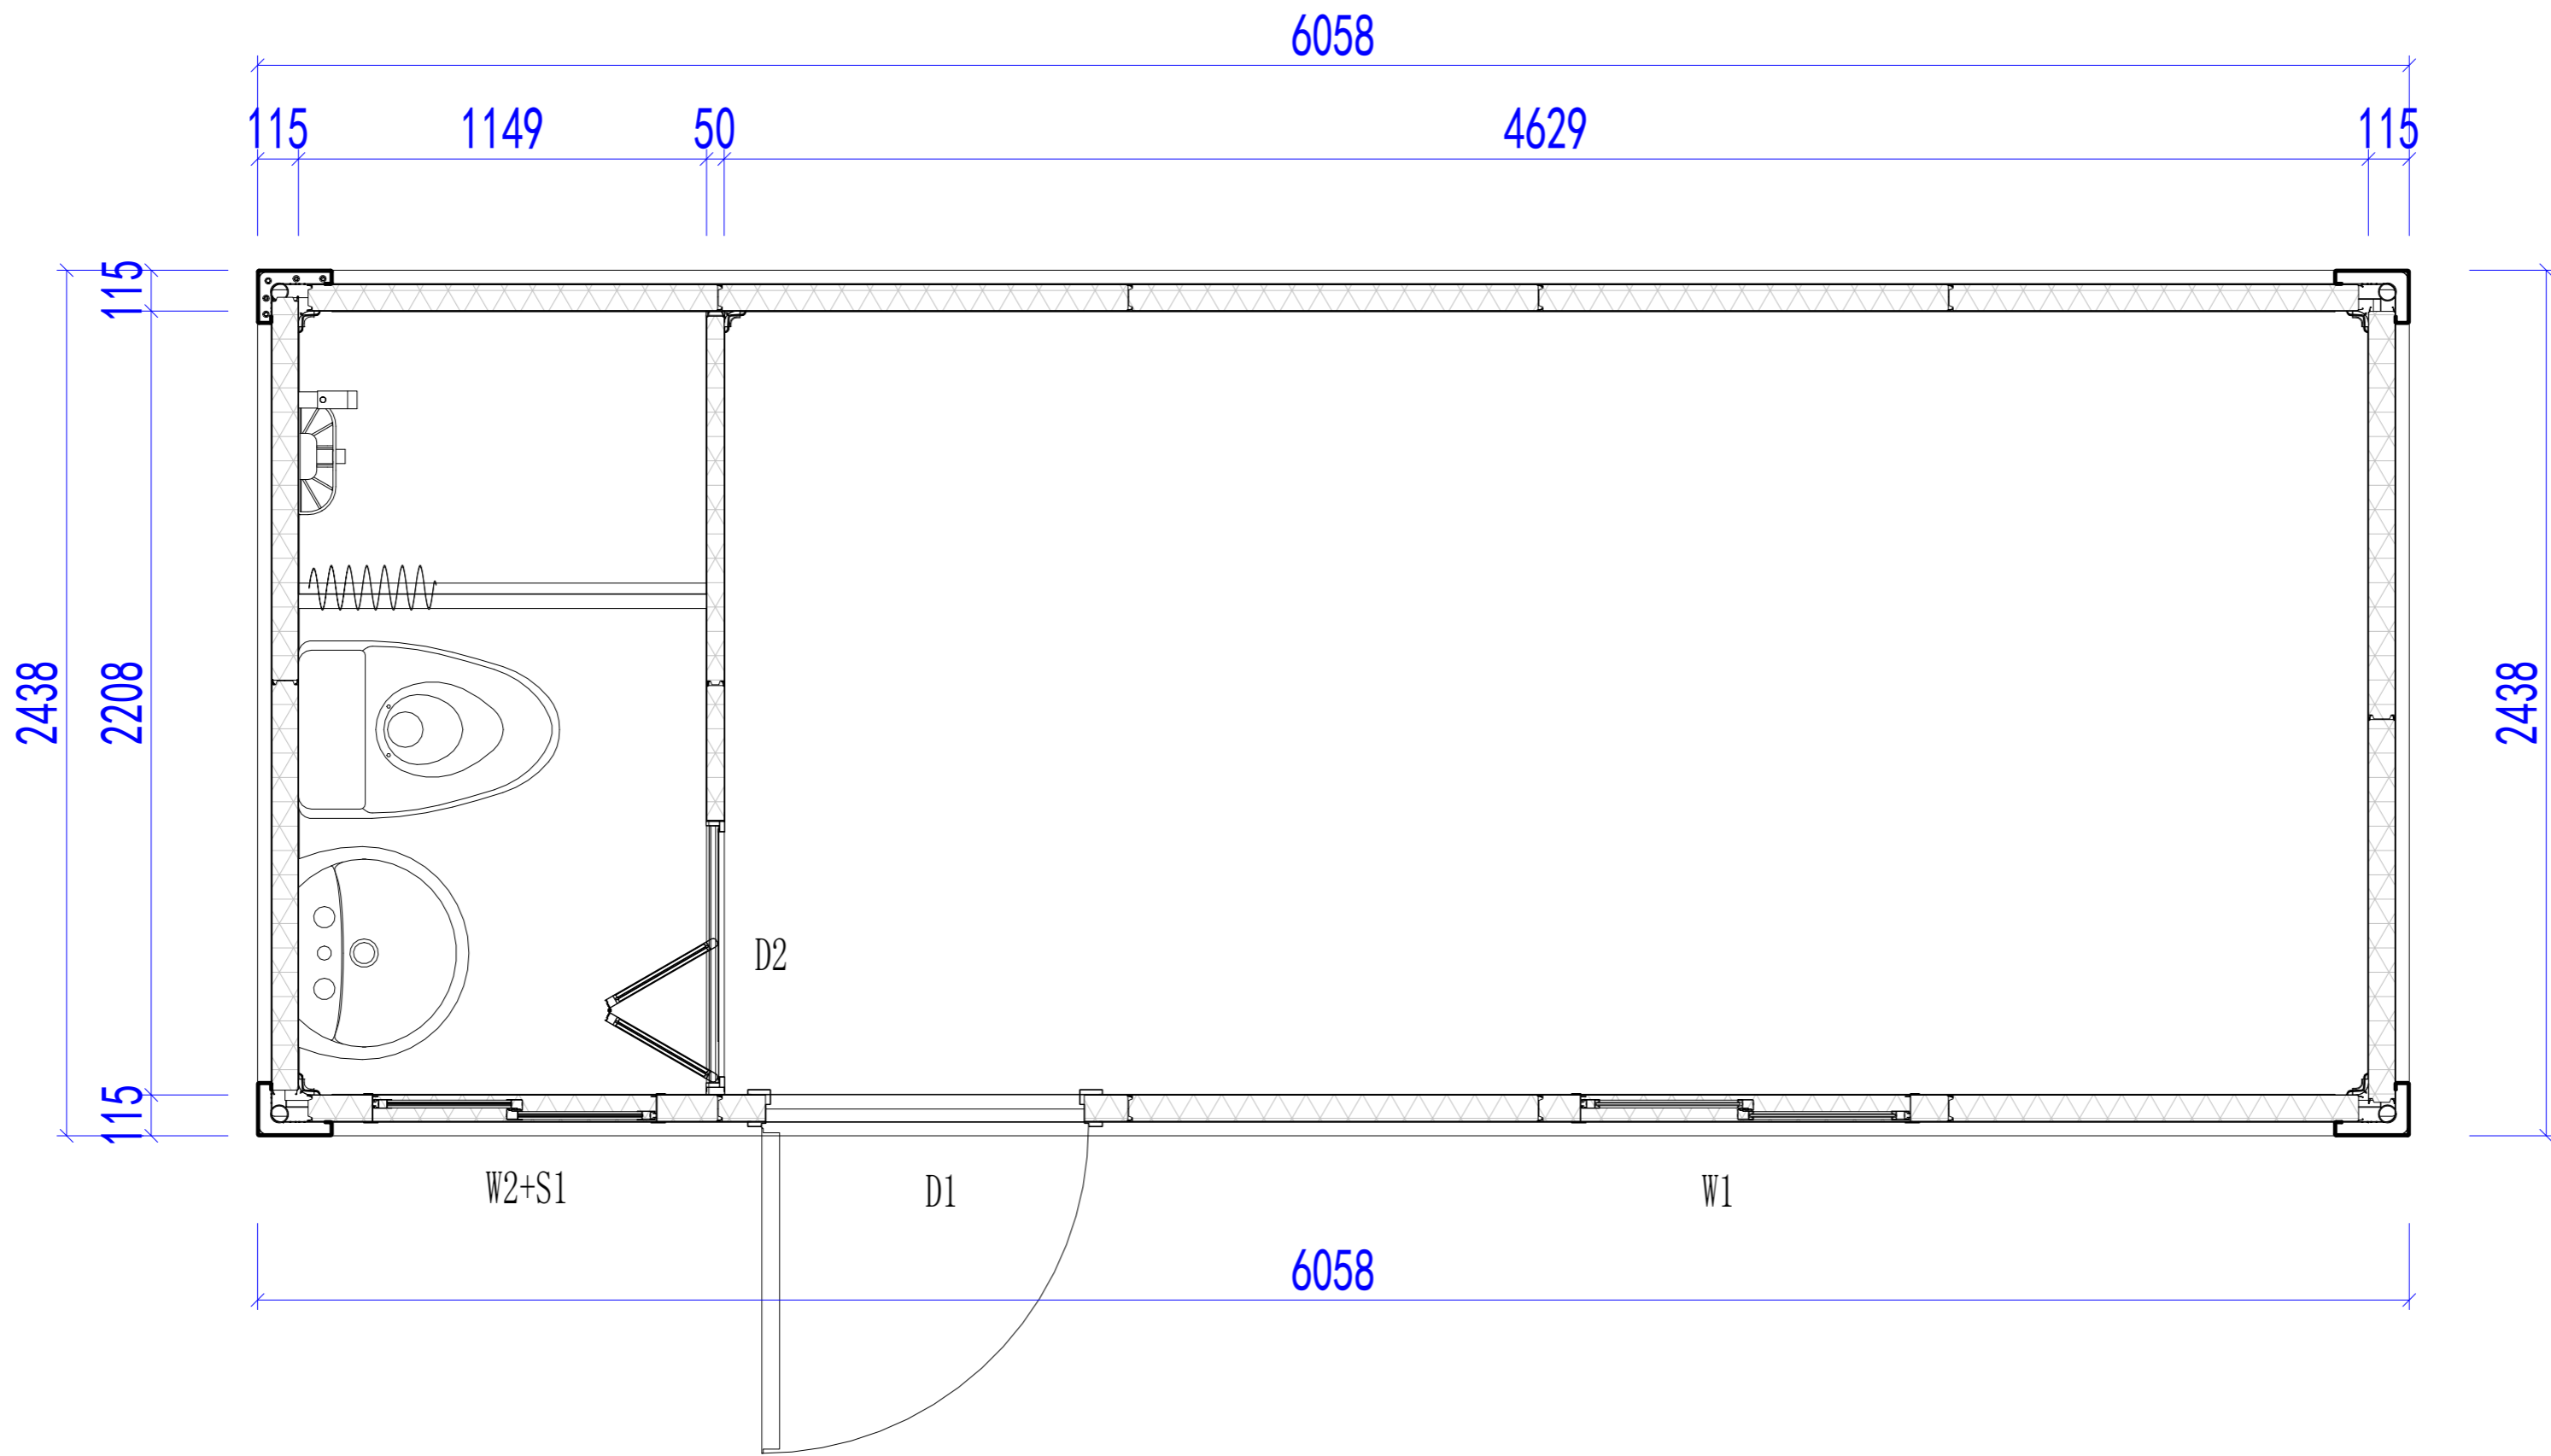

LAYOUT PLAN

Copyright 2016.
 本图版权归浙江普天集成房屋有限公司所有，基本工图版权归浙江普天集成房屋有限公司所有。
 THE OWNERSHIP OF THE COPYRIGHT IN THIS DRAWING REMAINS BY ZHEJIANG PUTIAN INTEGRATED HOUSING CO., LTD. WRITTEN CONSENT MUST BE OBTAINED BEFORE ANY REPRODUCTION OF THE DRAWING.

Rev.	Description	Date	Who send
------	-------------	------	----------



Zhejiang Putian integrated housing Co., Ltd.
 Hangzhou Zhongou Architecture Design (Institute) Co., Ltd.

证书等级	
证书编号	

合作设计单位
 Cooperative Designer

工序 Process	签名 Signature	日期 Date
审定 Authorized By		
审核 Verified By		
项目负责人 Process		
校对 Checked By		
设计 Designed By		
制图 Drawn By		

执业印章
 Engineer Signature

出图印章
 Engineer Signature


项目名称
 Project Name
 澳大利亚-集装箱

题名
 Title
 平面布置图

工程编号 No.	PT220307	专业 Prof.	JZ
比例 Scale		图号 No.	J0-4

未盖技术出图章 本图纸无效
 This drawing is valid only after being stamped and
 This drawing is invalid if not stamped.


电力	照明	动力
暖通	给排水	
结构		
密封		

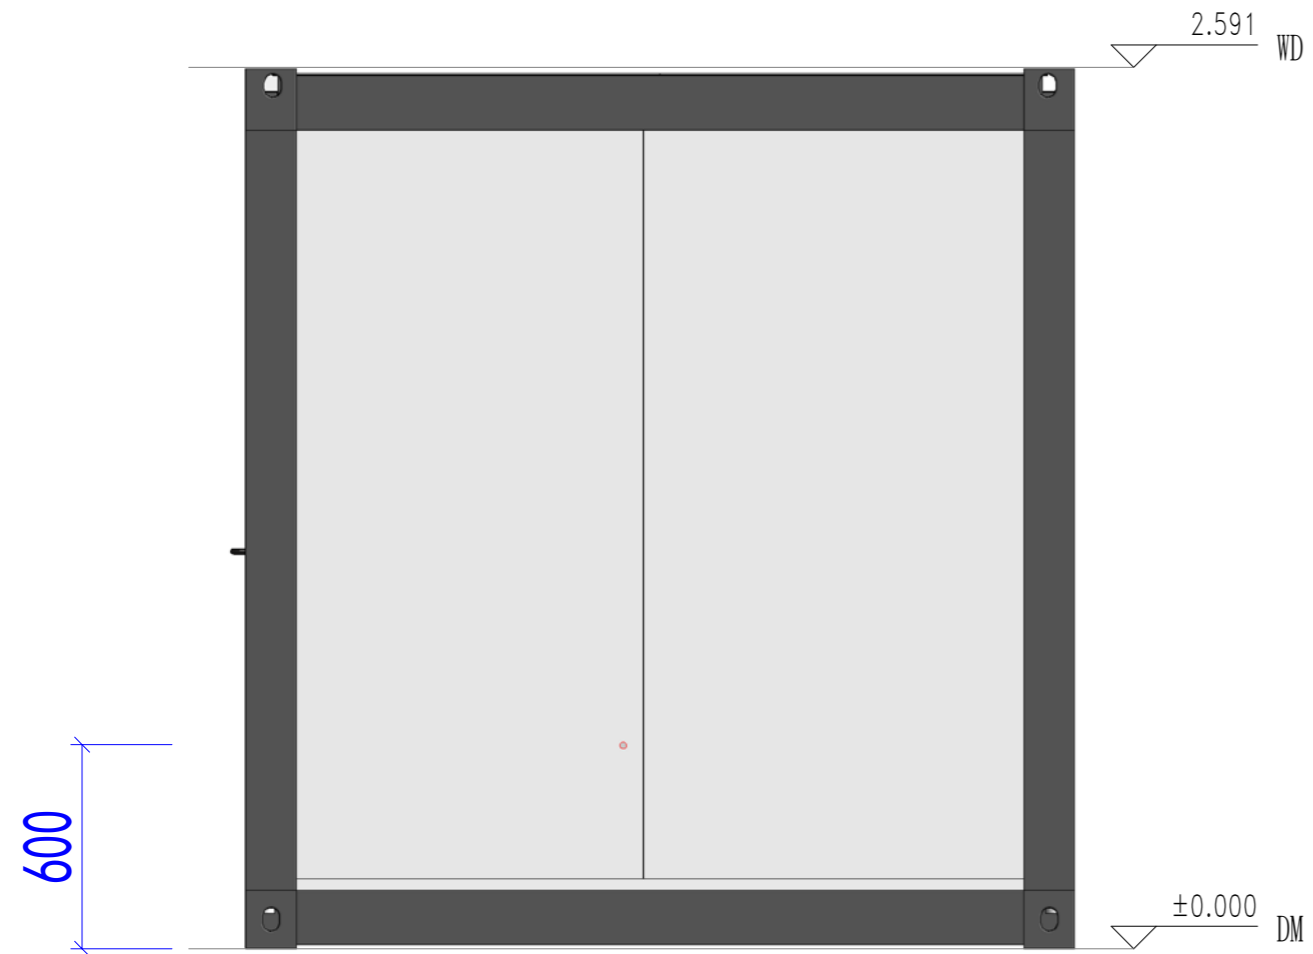


EAST



SOUTH

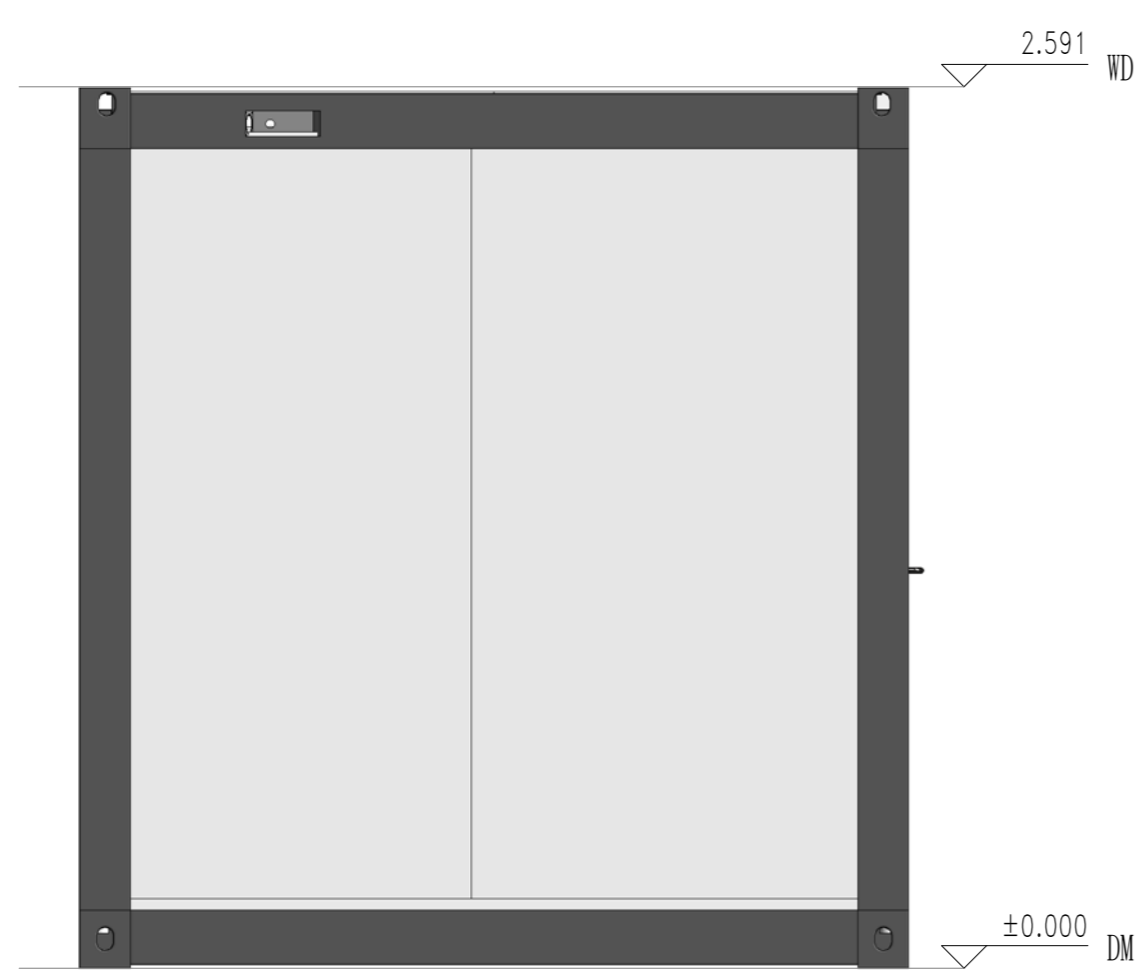

WEST

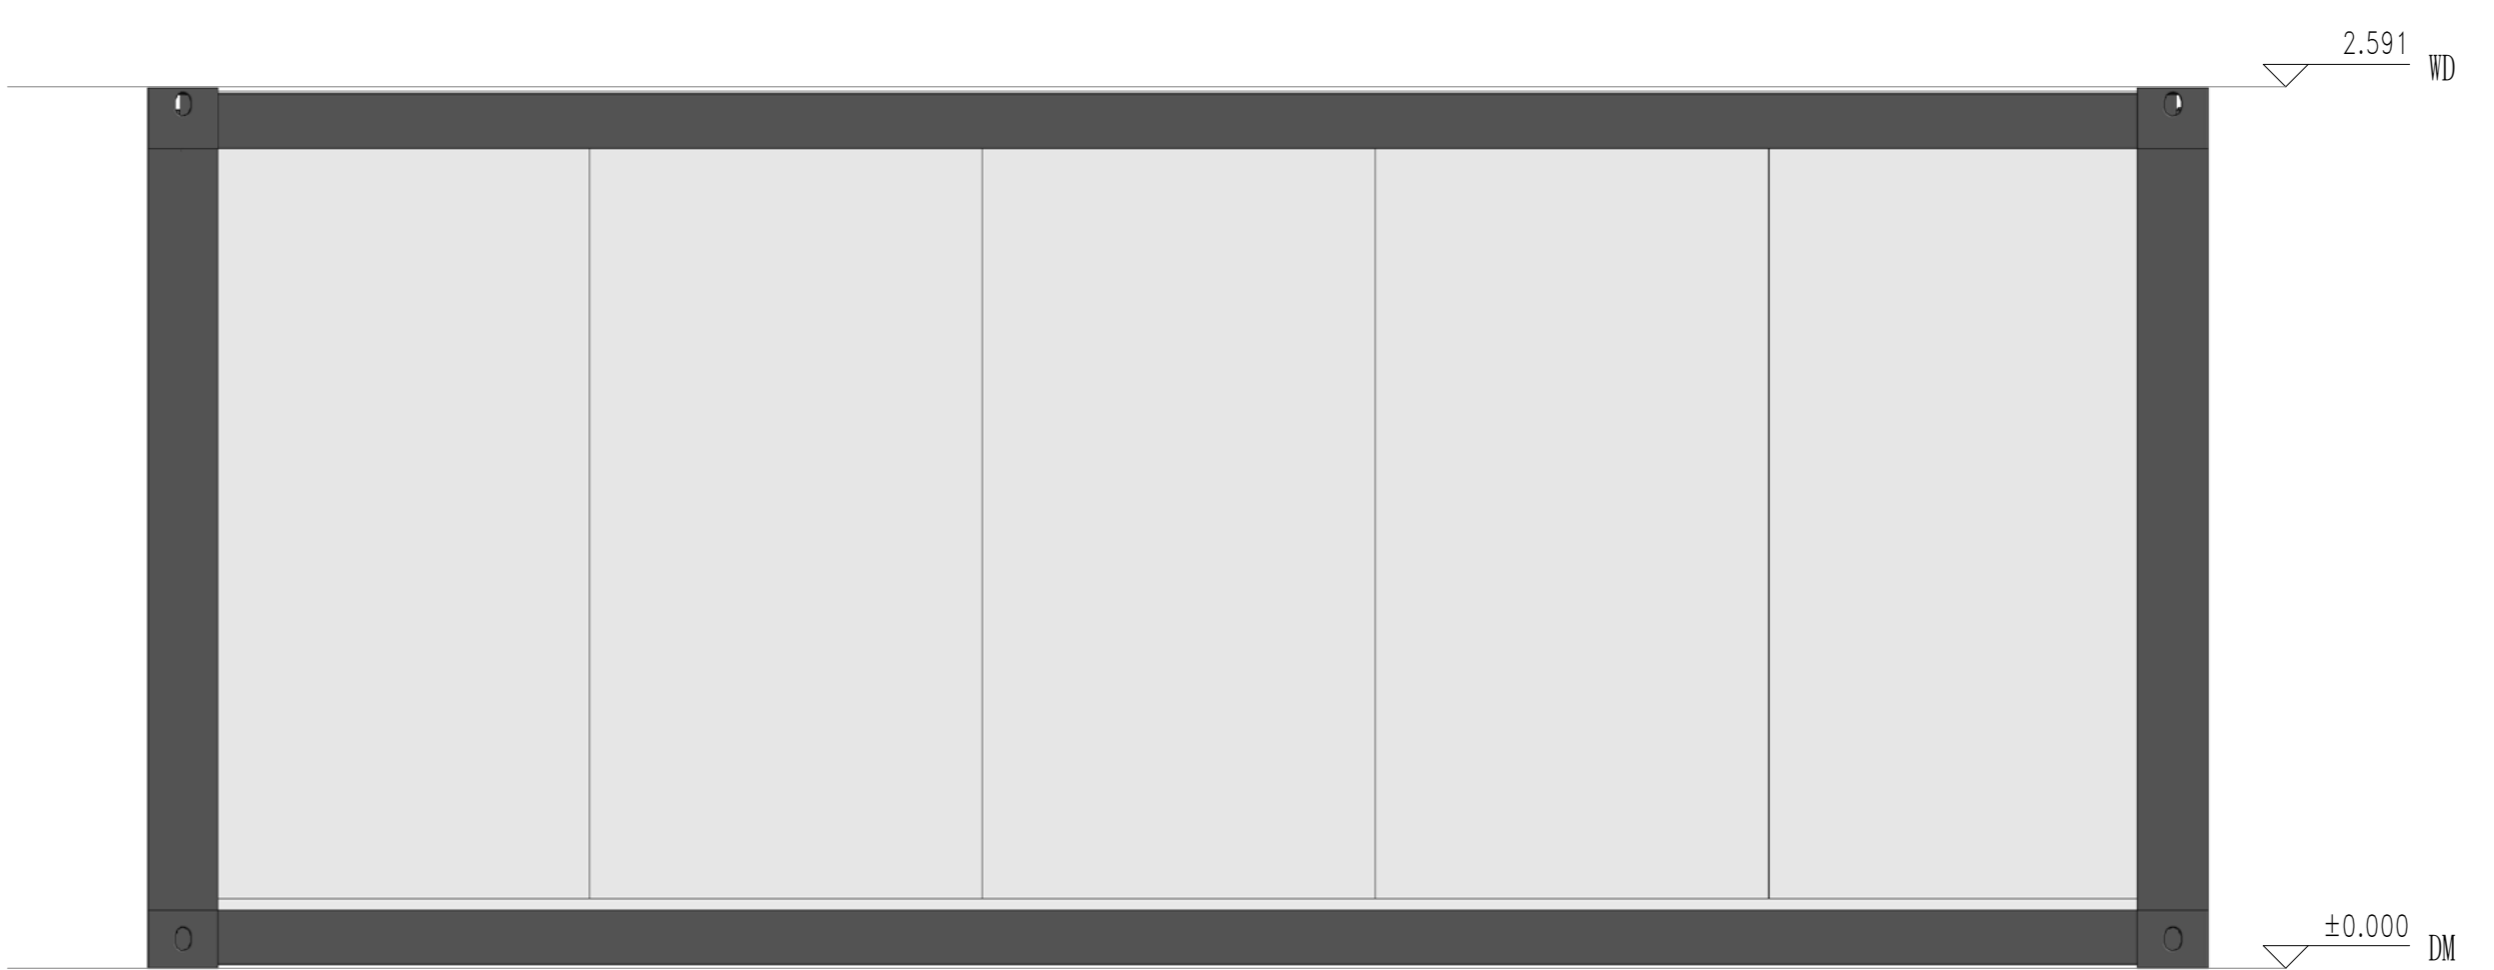

NORTH

Copyright 2016.
 本图版权归浙江普天集成房屋有限公司所有，基本工图中本图的所有权均归浙江普天集成房屋有限公司所有。
 THE OWNERSHIP OF THE COPYRIGHT IN THIS DRAWING REMAINS BY ZHEJIANG PUTIAN INTEGRATED HOUSING CO., LTD. WRITTEN CONSENT MUST BE OBTAINED BEFORE ANY REPRODUCTION OF THE DRAWING.

证书编号	证书等级
合作设计单位	

PTH
 Zhejiang Putian integrated housing Co., Ltd.
 Hangzhou Zhongou Architecture Design (Institute) Co., Ltd.

工序 Process	签名 Signature	日期 Date
审定 Authorized By		
审核 Verified By		
项目负责人 Process		
校对 Checked By		
设计 Designed By		
制图 Drawn By		

执业印章
 Engineer Signature


项目名称
 Project Name
澳大利亚-集装箱

题名
立面布置图

工程编号 No.	PT220307	专业 Prof.	JZ
比例 Scale		图号 Drawing No.	J0-5

未盖技术出图章 本图纸无效
 This drawing is valid only after being stamped and signed.

电力	暖通	动力
结构	给排水	
会	密	

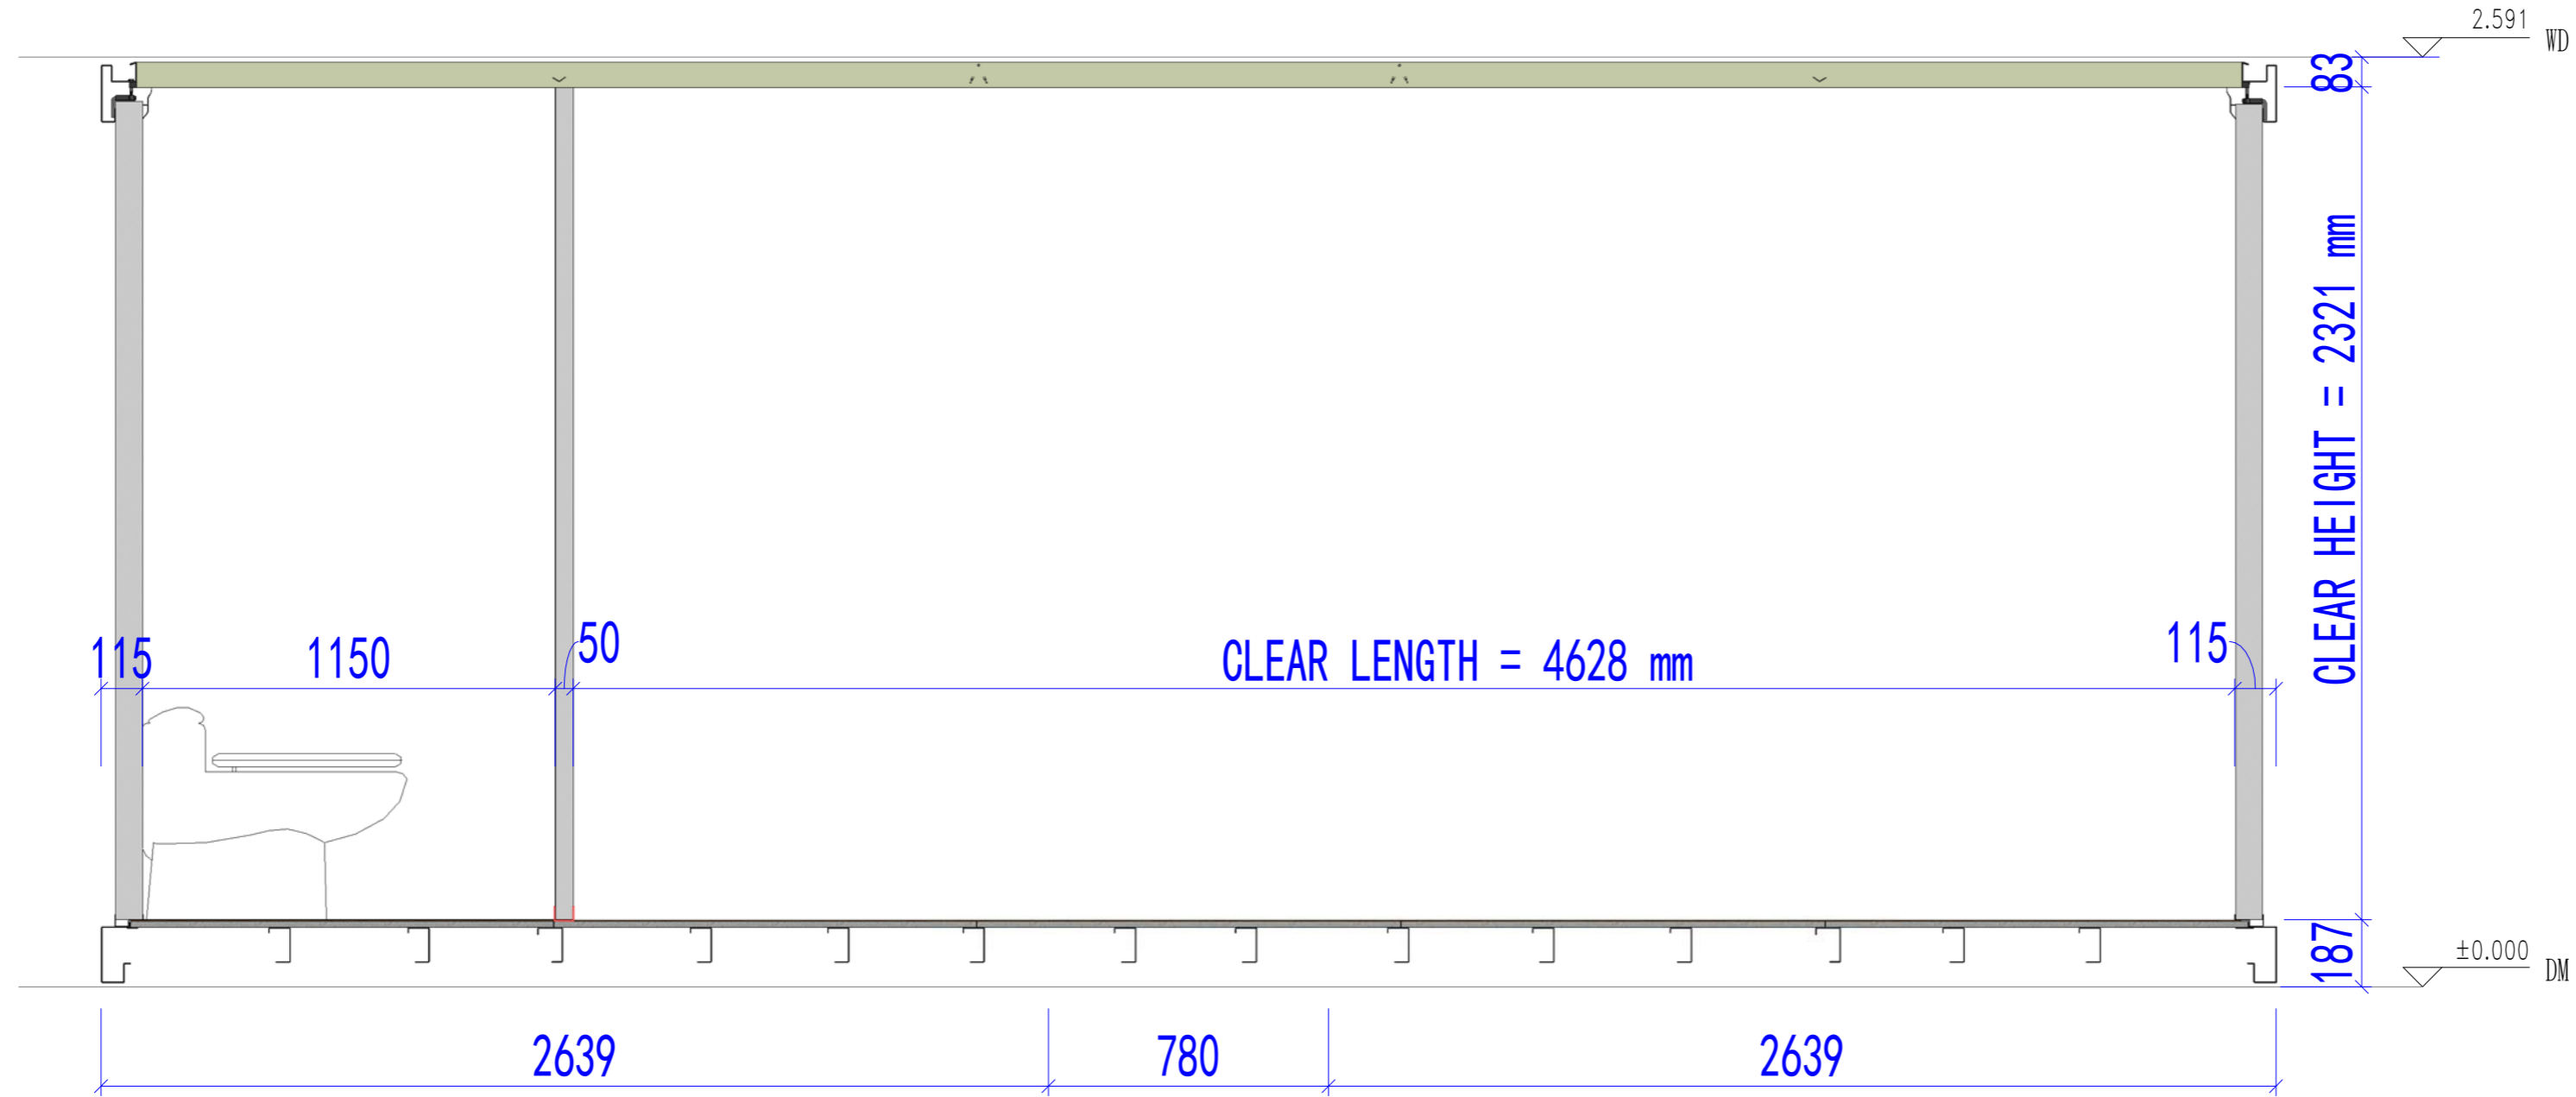

SECTION PLAN

Copyright 2016.
 本图版权归浙江普天集成房屋有限公司所有，基本工图中本图的技术内容均受法律保护。
 THE OWNERSHIP OF THE COPYRIGHT IN THIS DRAWING REMAINS WITH ZHEJIANG PUTIAN INTEGRATED HOUSING CO., LTD. WRITTEN CONSENT MUST BE OBTAINED BEFORE ANY REPRODUCTION OF THE DRAWING.

Rev.	Description	Date	Who send
------	-------------	------	----------



Zhejiang Putian integrated housing Co., Ltd.
 Hangzhou Zhonggu Architecture Design (Institute) Co., Ltd.

证书等级	
证书编号	

合作设计单位
 Cooperative Designer

工序 Process	签名 Signature	日期 Date
审定 Authorized By		
审核 Verified By		
项目负责人 Process		
校对 Checked By		
设计 Designed By		
制图 Drawn By		

执业印章
 Engineer Signature

出图印章
 Engineer Signature

项目名称
 Project Name
 澳大利亚-集装箱

题名
 Title
 剖面布置图

工程编号 No.	PT220307	专业 Prof.	JZ
比例 Scale		图号 Drawing No.	J0-6

未盖技术出图章 本图纸无效
 This drawing is valid only after being stamped and
 This drawing is invalid without the technical drawing stamp.

电力	照明	动力
暖通	给排水	
结构		
其他		

Copyright 2016.
 本图版权归浙江普天集成房屋有限公司所有，基本工图中对本图的任何修改均须经本图编制人同意。
 THE OWNERSHIP OF THE COPYRIGHT IN THIS DRAWING REMAINS WITH ZHEJIANG PUTIAN INTEGRATED HOUSING CO., LTD. WRITTEN CONSENT MUST BE OBTAINED BEFORE ANY REPRODUCTION OF THE DRAWING.

Rev.	Description	Date	Who send
------	-------------	------	----------



Zhejiang Putian integrated housing Co., Ltd.
 Hangzhou Zhonggu Architecture Design (Institute) Co., Ltd.

证书等级
 证书编号

合作设计单位
 Cooperative Designer

工序 Process	签名 Signature	日期 Date
审定 Authorized By		
审核 Verified By		
项目负责人 Process		
校对人 Checked By		
设计 Designed By		
制图 Drawn By		

执业签章
 Engineer Signature

出图签章
 Engineer Signature


项目名称
 Project Name
 澳大利亚-集装箱

题名
 Title
 电力布置图

工程编号
 PT220307
 专业
 JZ

比例
 1:1
 图号
 J0-7

未盖技术出图章 本图纸无效
 This drawing is valid only after being stamped and signed.

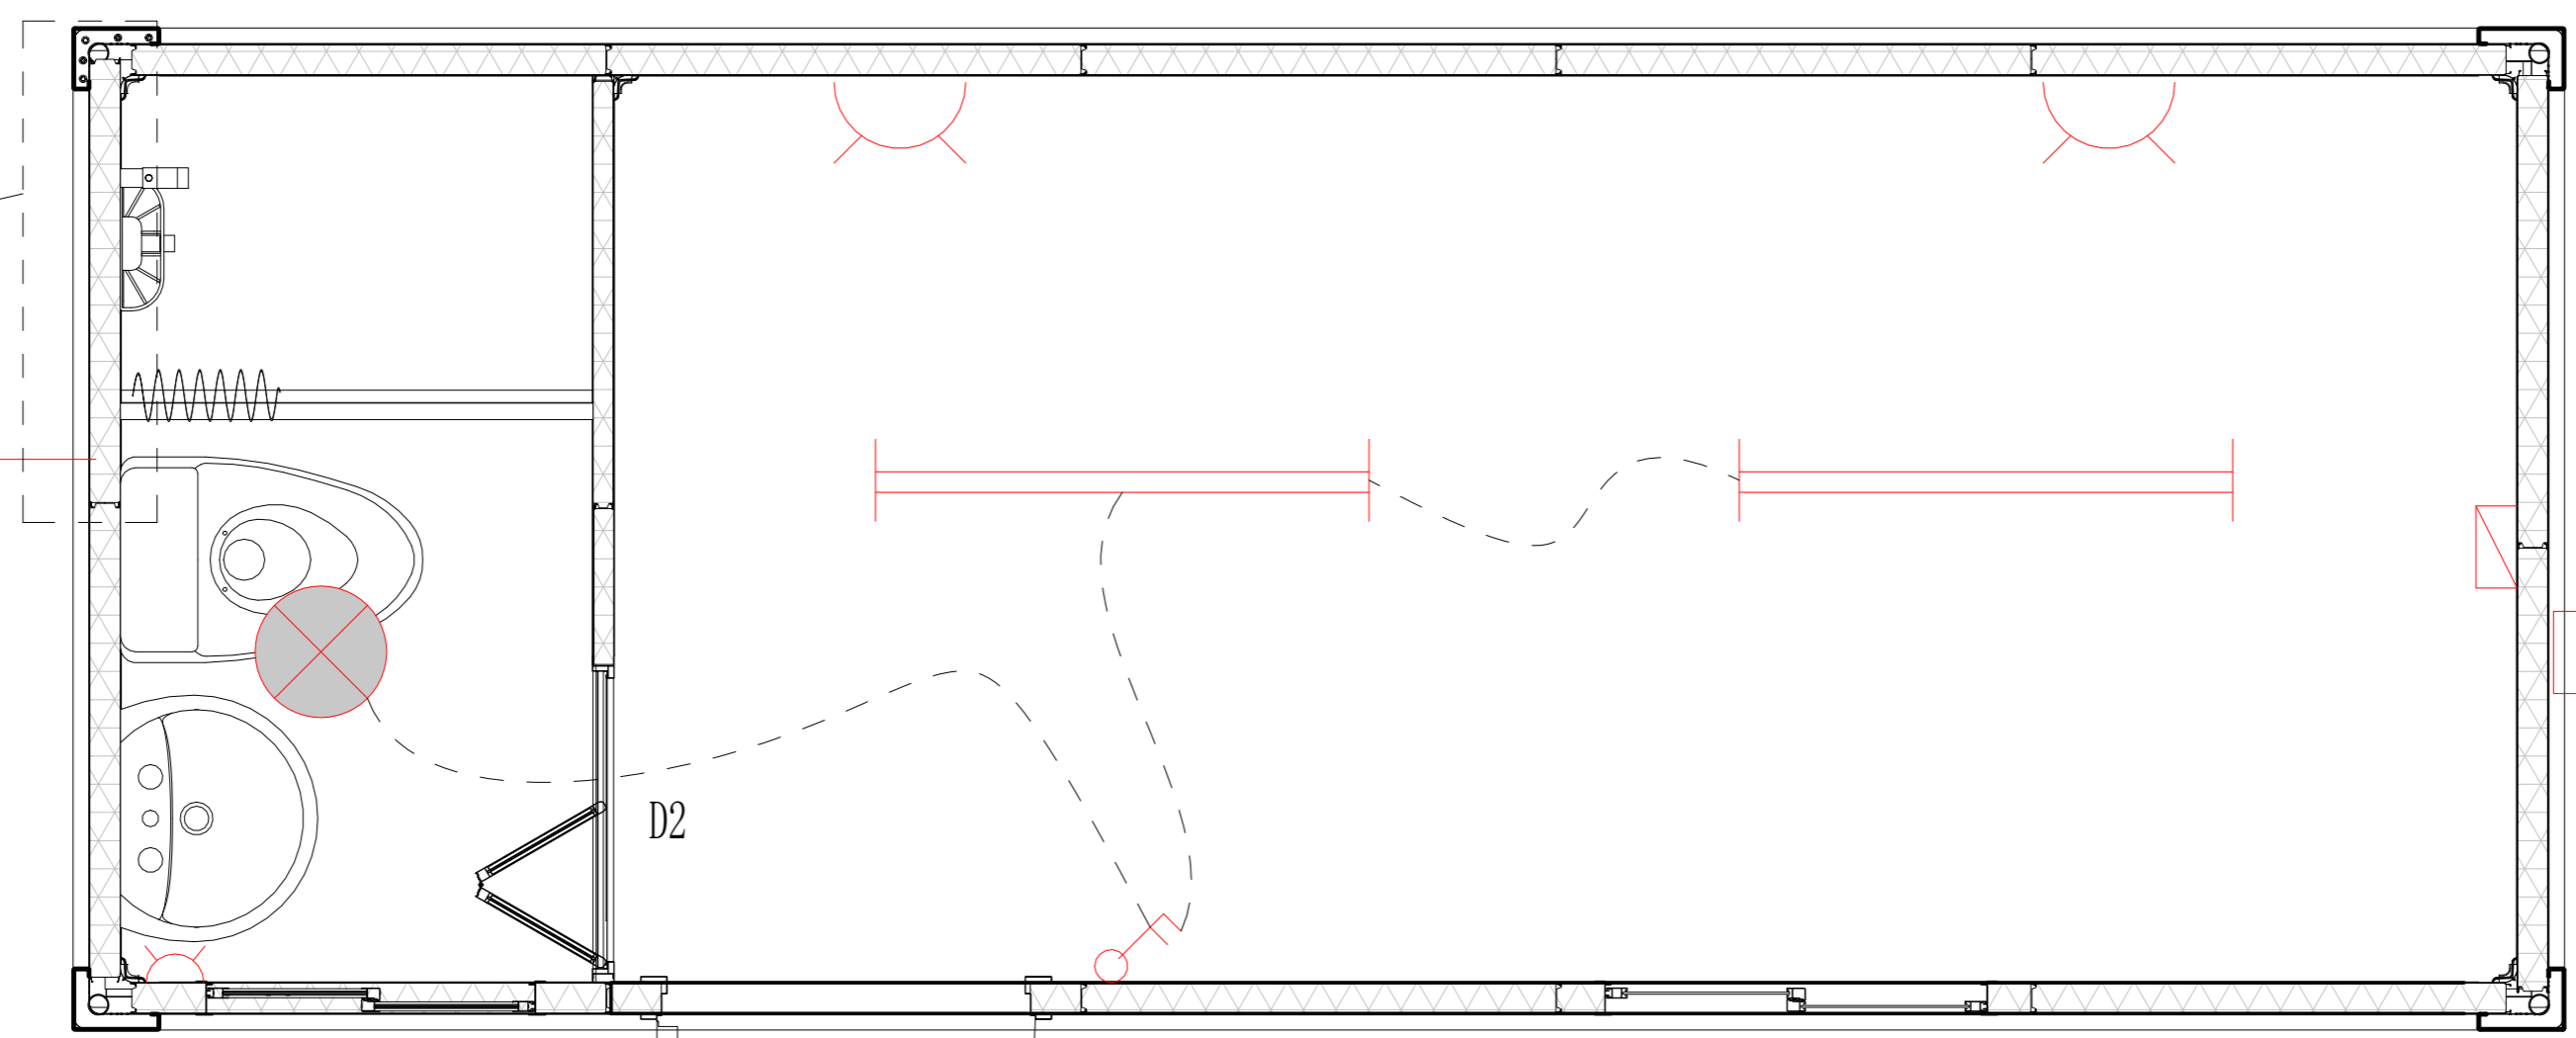


ELECTRICAL PLAN


Water Heater
 (by client)

See "Wall Panel Detail"

D2

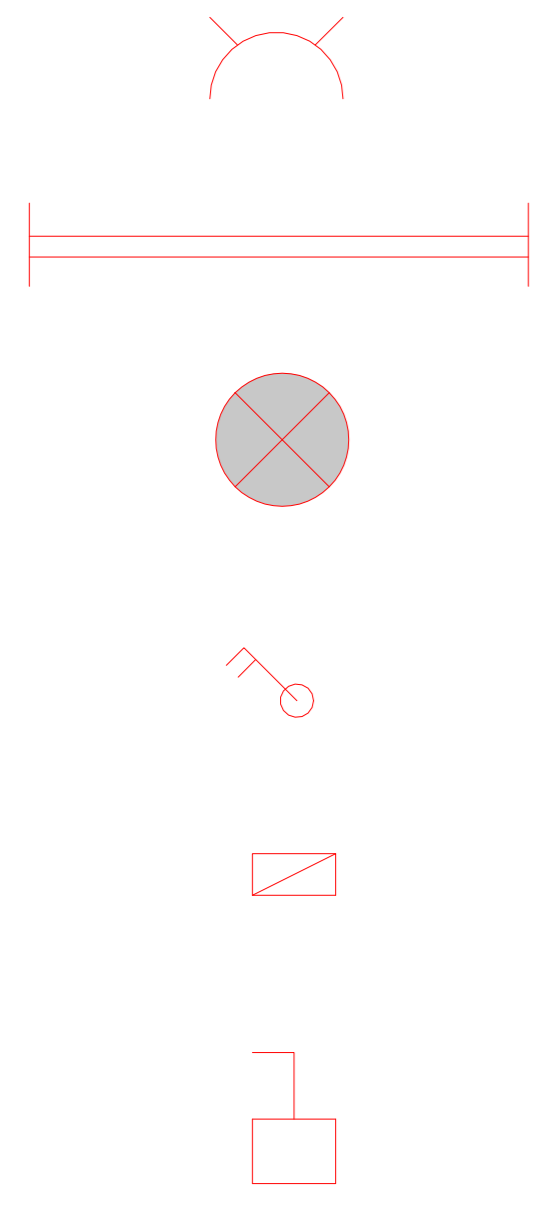

- Socket, H=300mm (only socket box) , horizontal
- Toilet socket, H=1200mm, (only socket box)with water-proof cover , horizontal
- 1200mmLED light,with earth connection
- Round ceiling lamp, with earth connection
- Double control switch, H=1200mm (only switch box) , vertical
- Distribution box (by client)
- Outdoor power connection (pre-assembly)

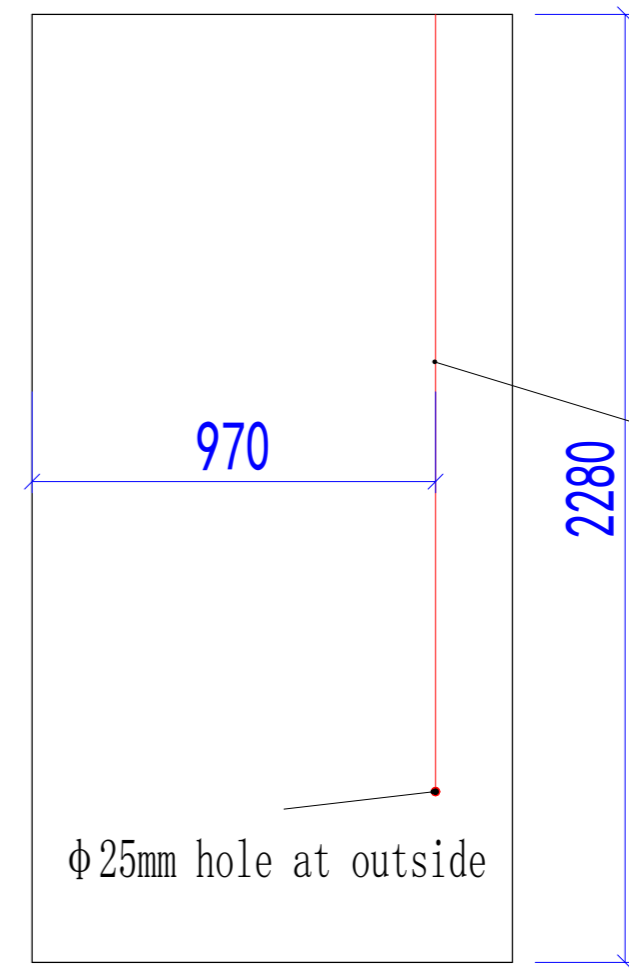

PVC conduit

Wall Panel Detail